


APPENDIX 3

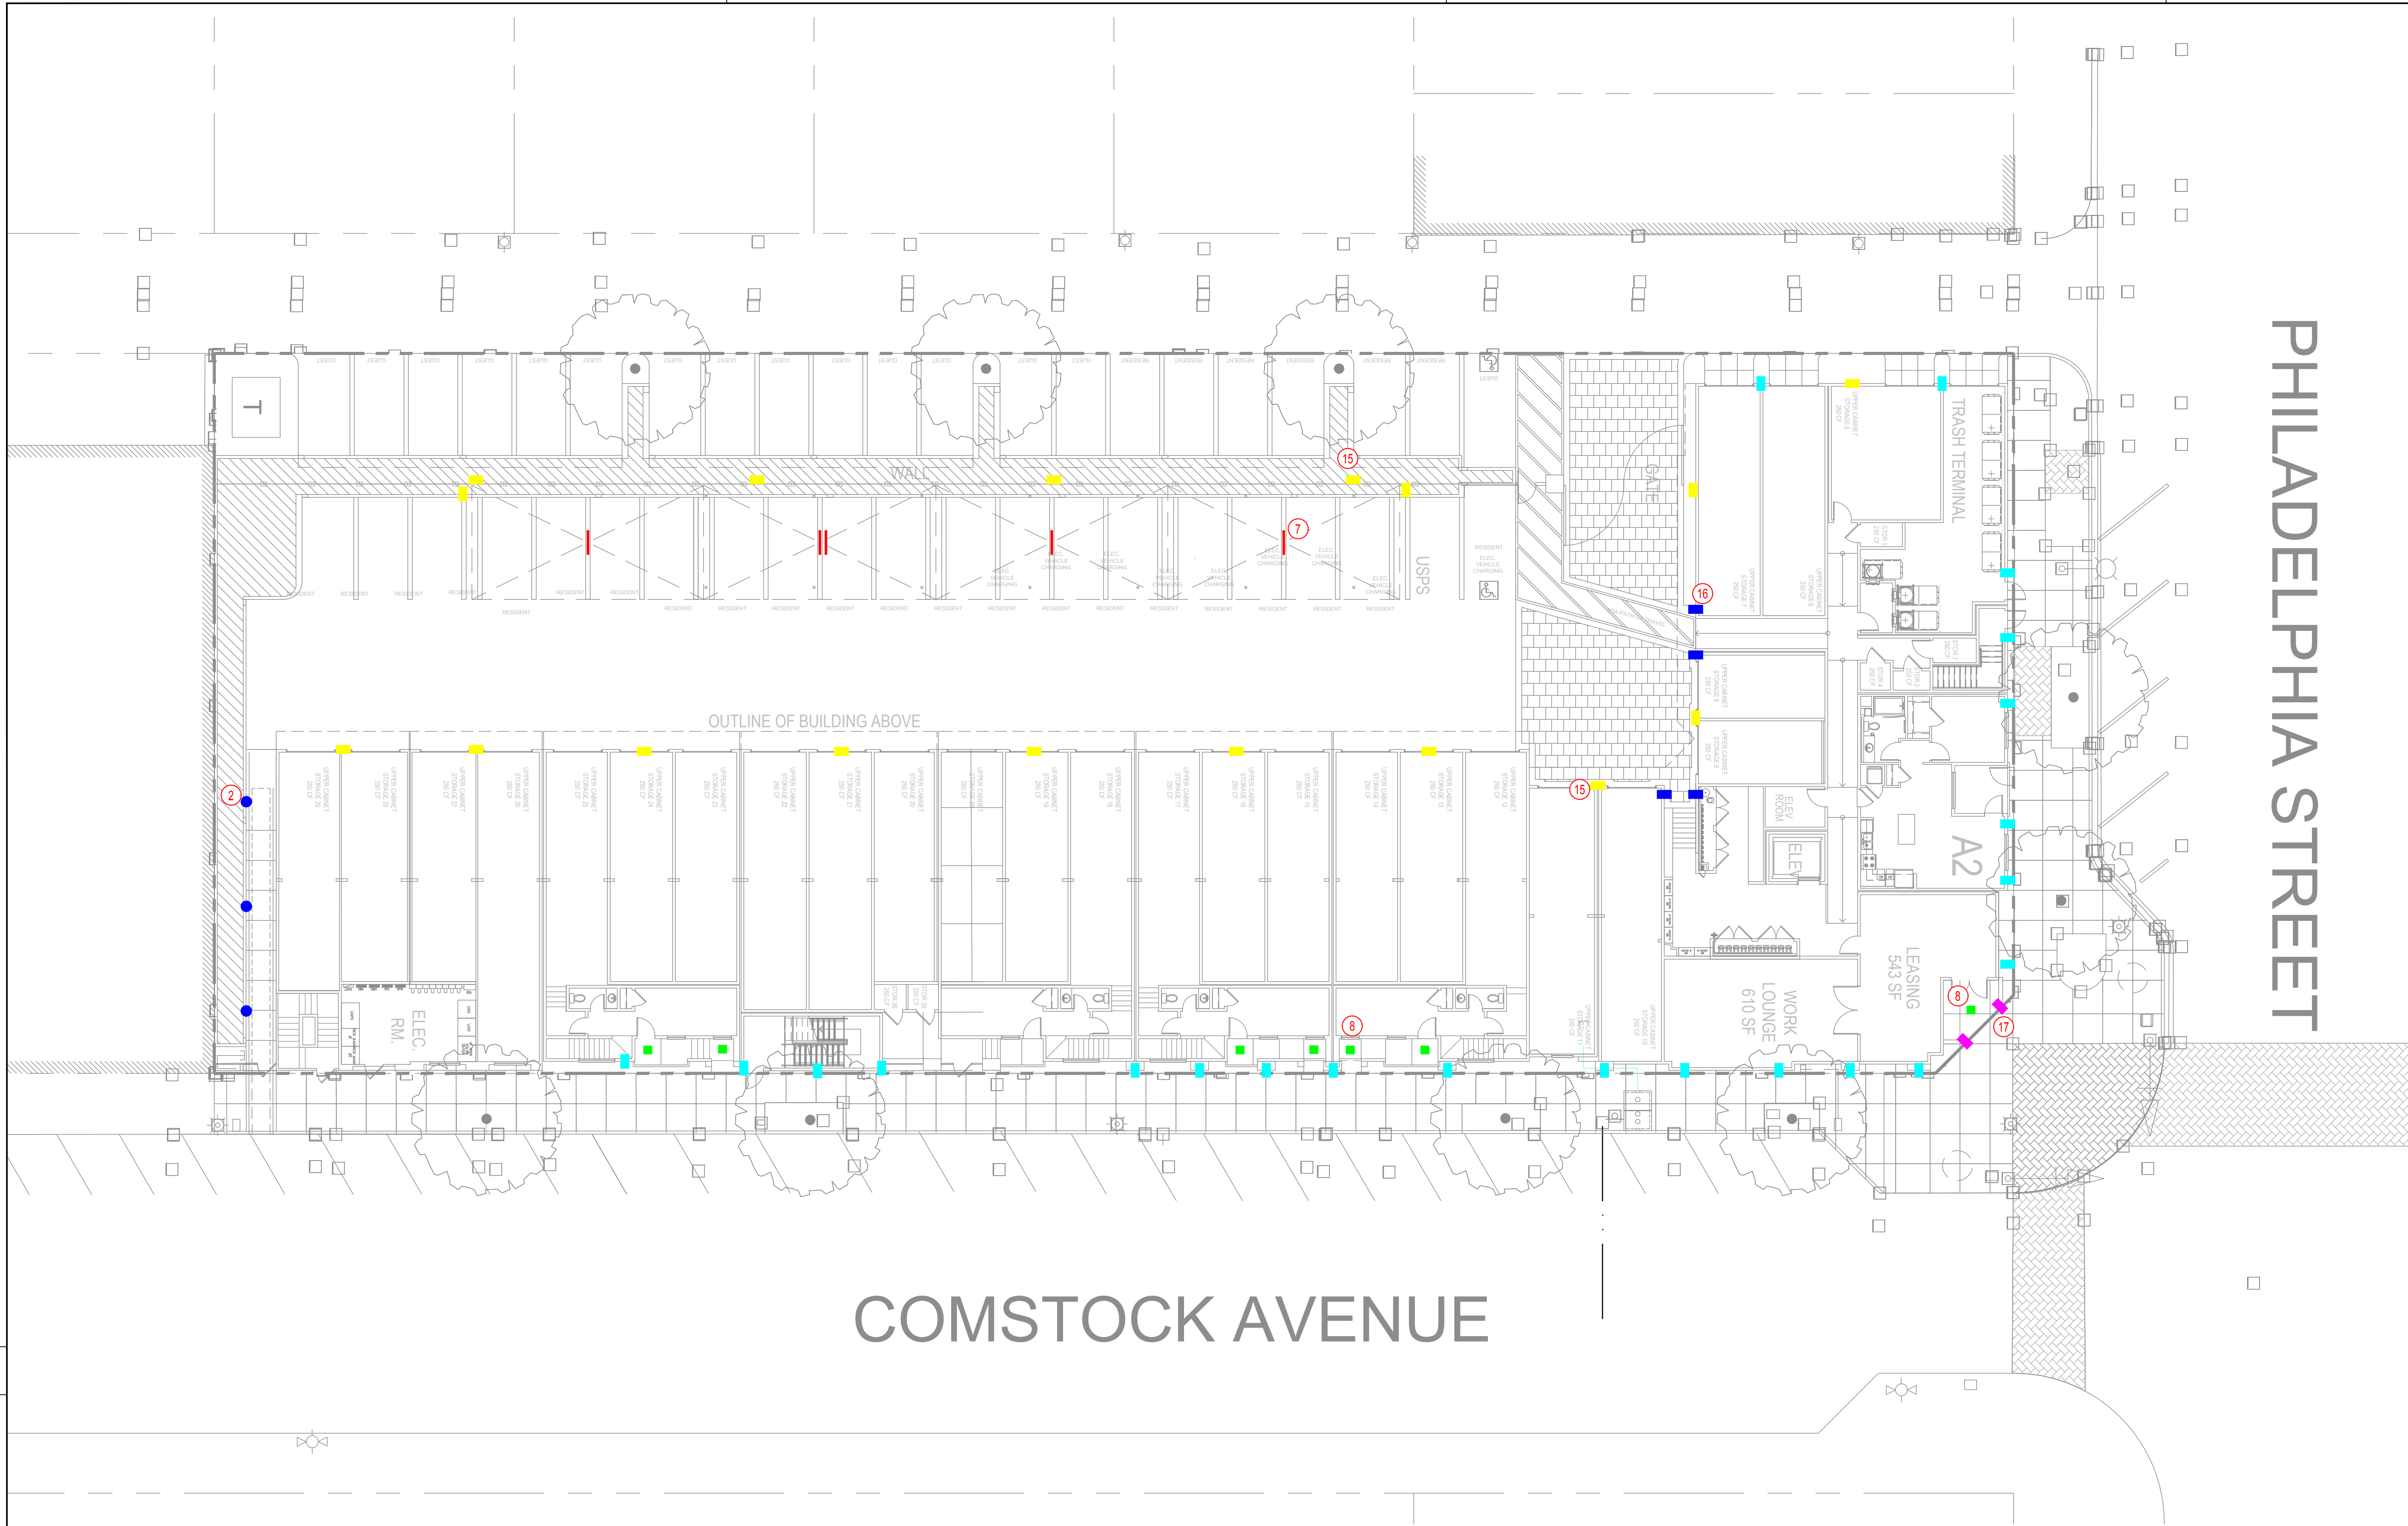

COMSTOCK AVENUE

PHILADELPHIA STREET


LIGHTING LEGEND

- 1 Type AL1 - Stake-mounted Adjustable LED Bullet Accent, 3000K
- 2 Type BH1 - 42" Tall LED Bollard Light, 3000K
- 3 Type DP1 - Decorative Outdoor Pendant, 3000K
- 4 Type DT1 - Decorative Outdoor Table Light, 3000K
- 5 Type FS1 - Surface Mounted LED Bullet Light on Trellis, 3000K
- 6 Type LS1 - Surface Mounted Linear LED Striplight, 3000K
- 7 Type LS2 - Canopy Mounted Linear LED Striplight, 3000K
- 8 Type RD1 - Recessed LED Downlight, 3000K
- 9 Type SC1 - Suspended LED Festoon String, 2500K
- 10 Type SS1 - Surface-mounted Linear LED Tapelight, 3000K
- 11 Type SS2 - Surface-mounted Linear LED Tapelight, 3000K
- 12 Type SZ1 - Handrail integrated LED Lighting, 3000K
- 13 Type WR1 - Wall-recessed LED Step Light, 3000K
- 14 Type WS1 - Surface-mounted LED Wall Sconce, 3000K
- 15 Type WS2 - Surface-mounted LED Wall Pack Light, 3500K
- 16 Type WS3 - Surface-mounted LED Wall Sconce, 3000K
- 17 Type WS4 - Surface-mounted LED Wall Sconce with Uplight and Downlight, 3000K

GROUND LEVEL LIGHTING PLAN



1/16"=1'-0" 0 8' 16' 32' 48'

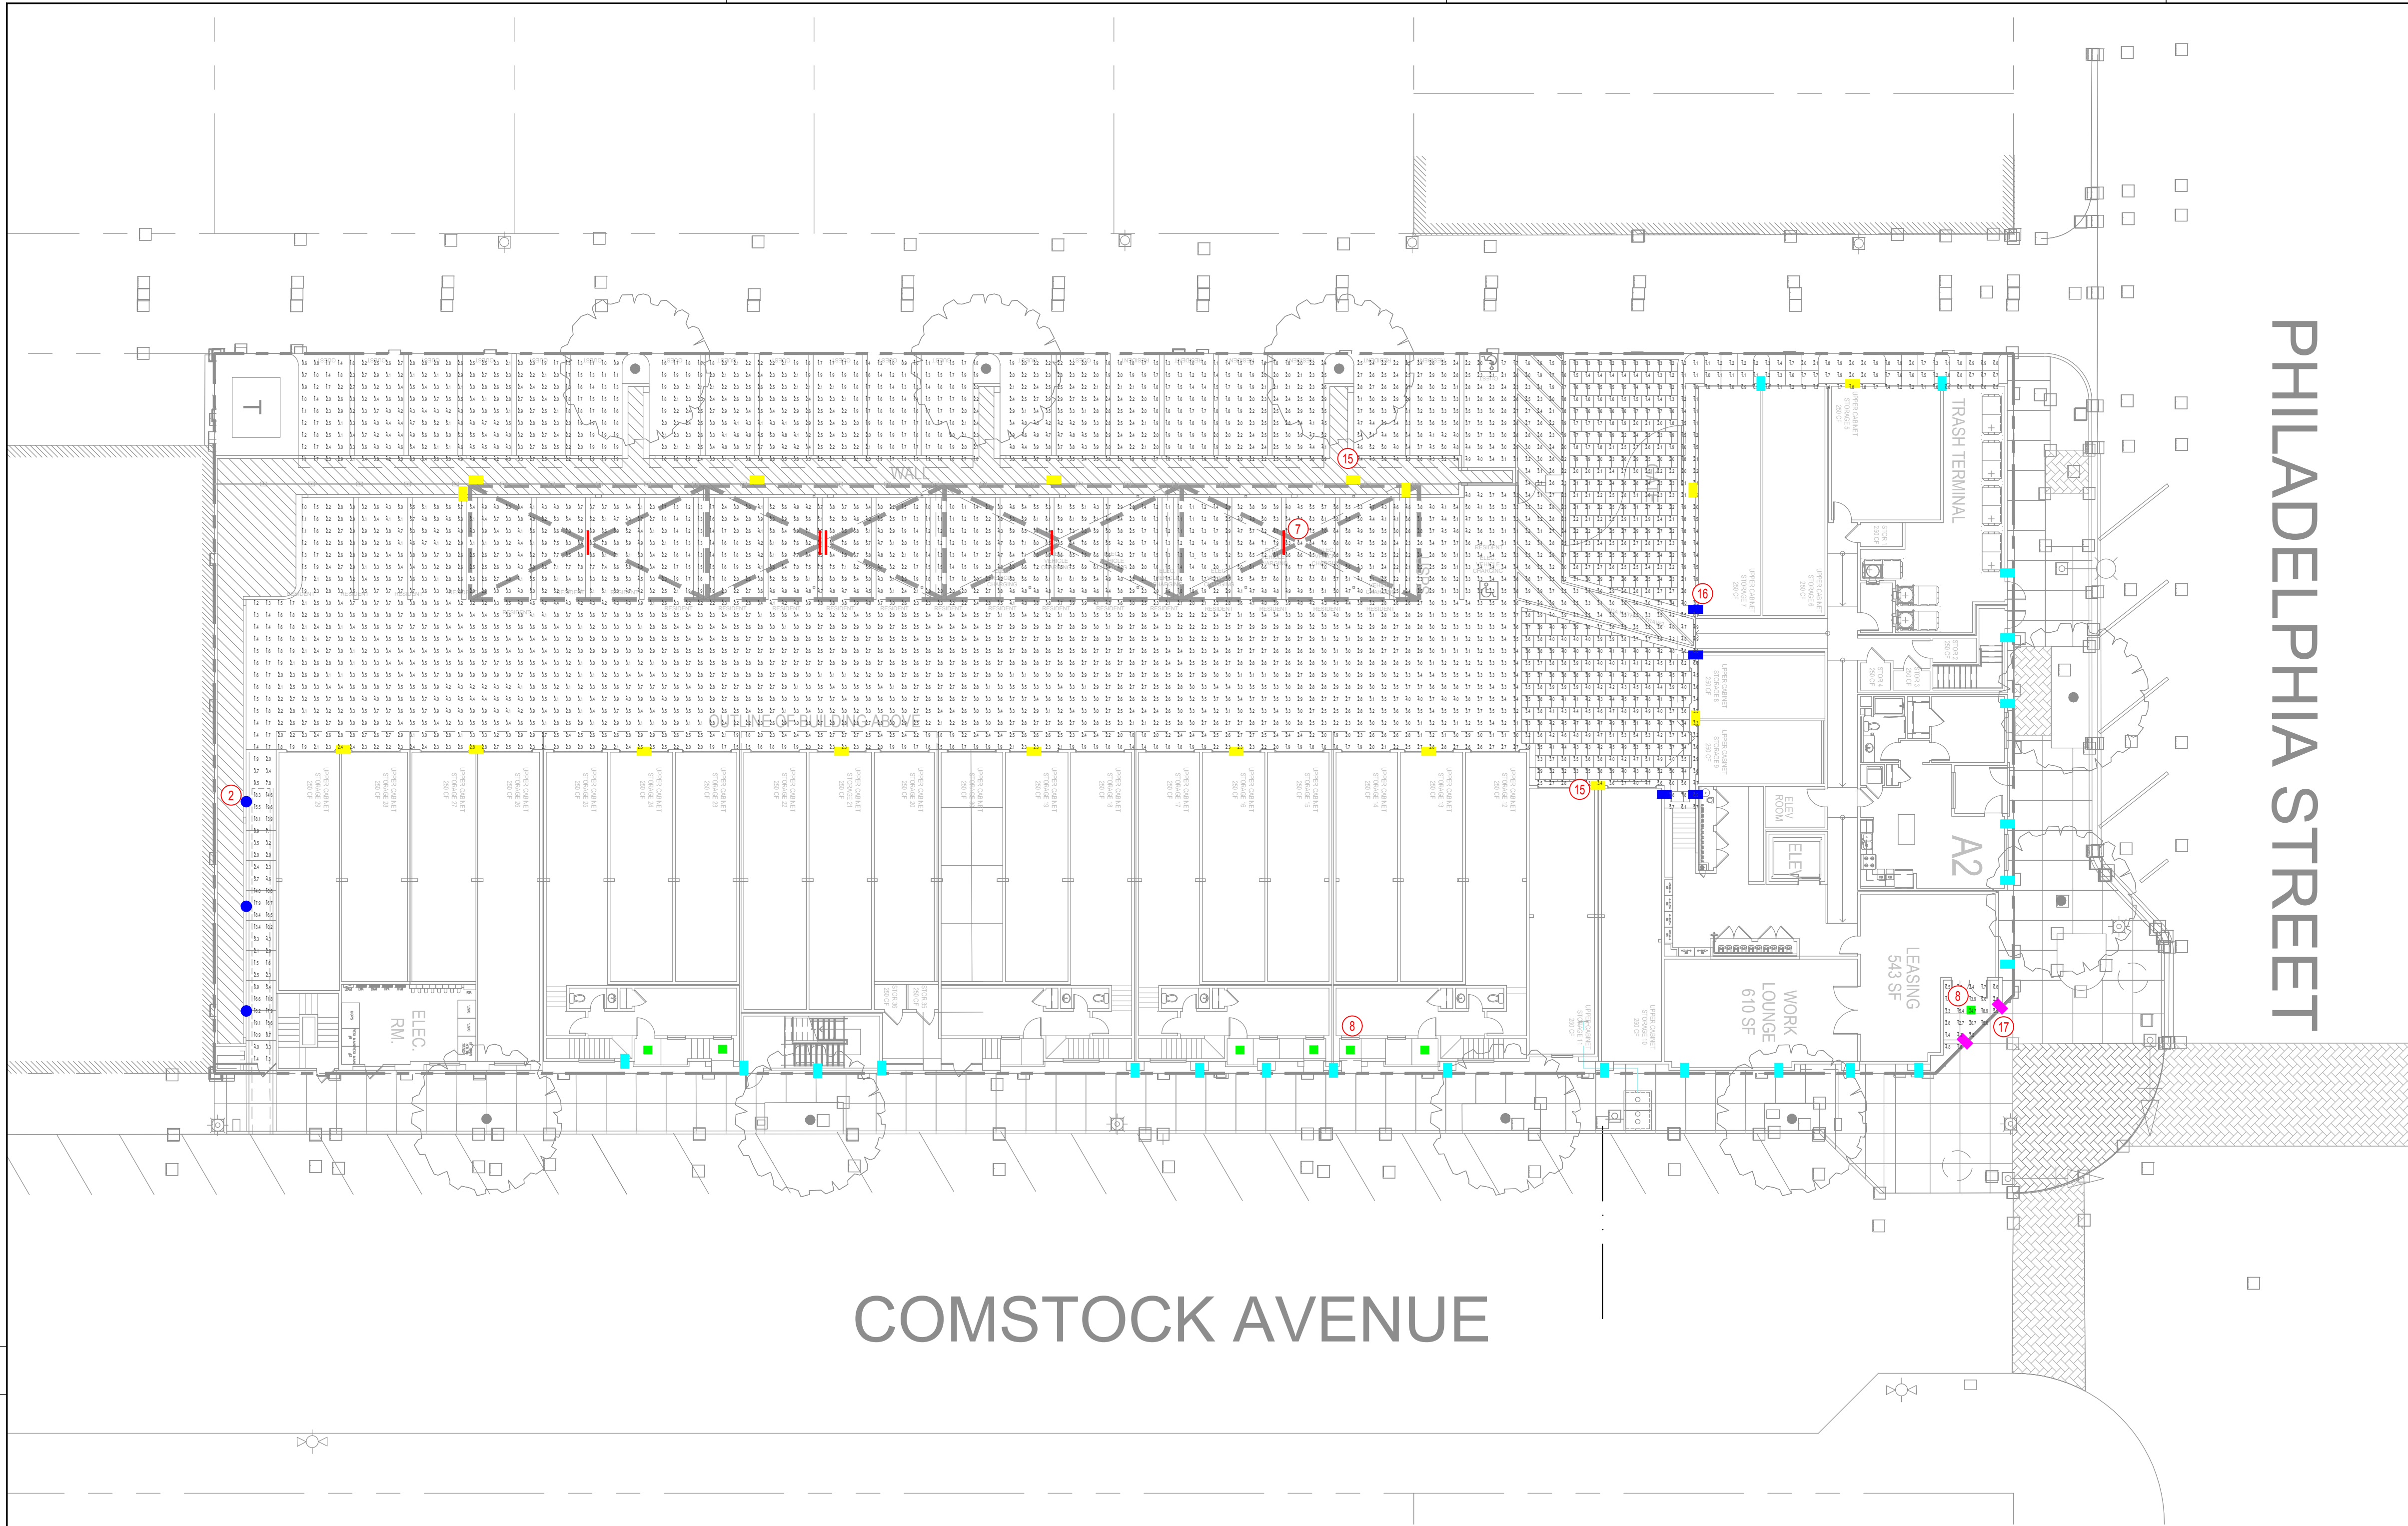



LIGHTING LEGEND

- 1 Type AL1 - Stake-mounted Adjustable LED Bullet Accent, 3000K
- 2 Type BH1 - 42" Tall LED Bollard Light, 3000K
- 3 Type DP1 - Decorative Outdoor Pendant, 3000K
- 4 Type DT1 - Decorative Outdoor Table Light, 3000K
- 5 Type FS1 - Surface Mounted LED Bullet Light on Trellis, 3000K
- 6 Type LS1 - Surface Mounted Linear LED Striplight, 3000K
- 7 Type LS2 - Canopy Mounted Linear LED Striplight, 3000K
- 8 Type RD1 - Recessed LED Downlight, 3000K
- 9 Type SC1 - Suspended LED Festoon String, 2500K
- 10 Type SS1 - Surface-mounted Linear LED Tapelight, 3000K
- 11 Type SS2 - Surface-mounted Linear LED Tapelight, 3000K
- 12 Type SZ1 - Handrail integrated LED Lighting, 3000K
- 13 Type WR1 - Wall-recessed LED Step Light, 3000K
- 14 Type WS1 - Surface-mounted LED Wall Sconce, 3000K
- 15 Type WS2 - Surface-mounted LED Wall Pack Light, 3500K
- 16 Type WS3 - Surface-mounted LED Wall Sconce, 3000K
- 17 Type WS4 - Surface-mounted LED Wall Sconce with Uplight and Downlight, 3000K

Calculation Summary								
Label	CalcType	Units	Avg	Max	Min	Avg/Min	Max/Min	Max/Avg
Site	Illuminance	Fc	3.19	24.7	0.5	6.38	49.40	7.74

 GROUND LEVEL PHOTOMETRIC CALCULATION PLAN



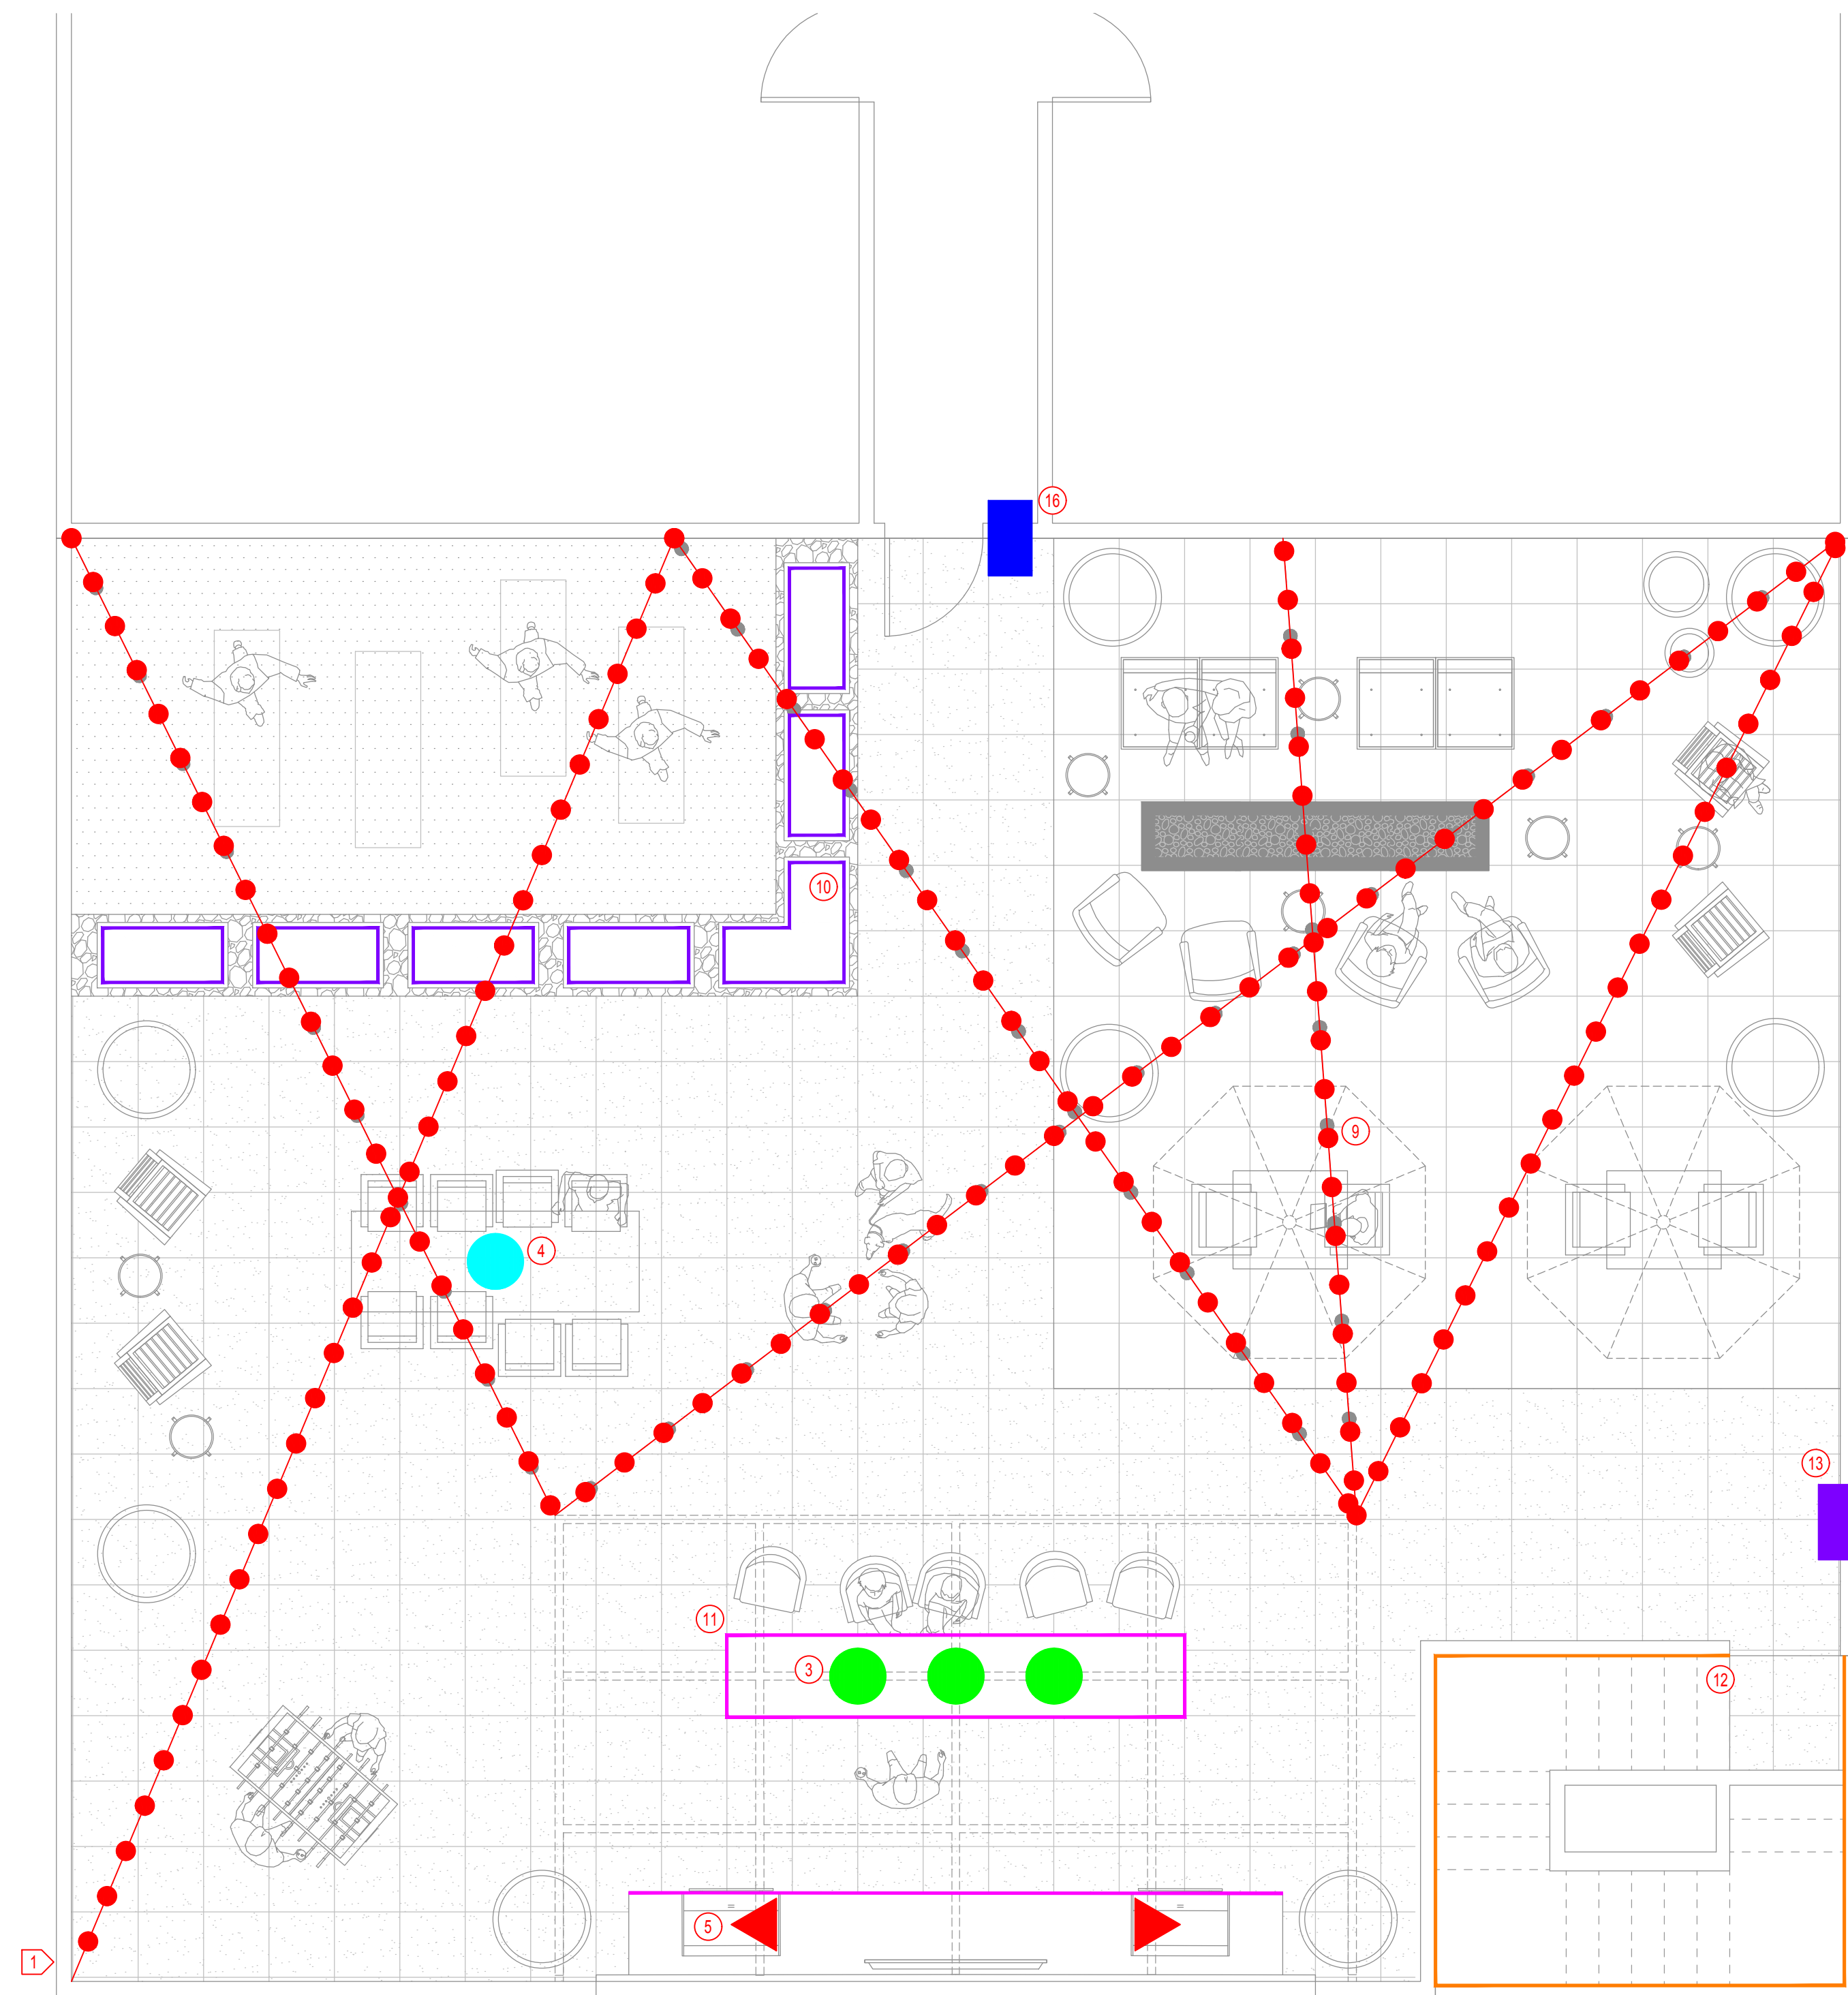

LEVEL 3 AMENITY DECK LIGHTING PLAN

LIGHTING LEGEND


- 1 Type AL1 - Stake-mounted Adjustable LED Bullet Accent, 3000K
- 2 Type BH1 - 42" Tall LED Bollard Light, 3000K
- 3 Type DP1 - Decorative Outdoor Pendant, 3000K
- 4 Type DT1 - Decorative Outdoor Table Light, 3000K
- 5 Type FS1 - Surface Mounted LED Bullet Light on Trellis, 3000K
- 6 Type LS1 - Surface Mounted Linear LED Striplight, 3000K
- 7 Type LS2 - Canopy Mounted Linear LED Striplight, 3000K
- 8 Type RD1 - Recessed LED Downlight, 3000K
- 9 Type SC1 - Suspended LED Festoon String, 2500K
- 10 Type SS1 - Surface-mounted Linear LED Tapelight, 3000K
- 11 Type SS2 - Surface-mounted Linear LED Tapelight, 3000K
- 12 Type SZ1 - Handrail integrated LED Lighting, 3000K
- 13 Type WR1 - Wall-recessed LED Step Light, 3000K
- 14 Type WS1 - Surface-mounted LED Wall Sconce, 3000K
- 15 Type WS2 - Surface-mounted LED Wall Pack Light, 3500K
- 16 Type WS3 - Surface-mounted LED Wall Sconce, 3000K
- 17 Type WS4 - Surface-mounted LED Wall Sconce with Uplight and Downlight, 3000K

KEYNOTE

- 1 Add a pole to support the festoon light.



1/4"=1'-0" 0 2' 4' 8' 12'

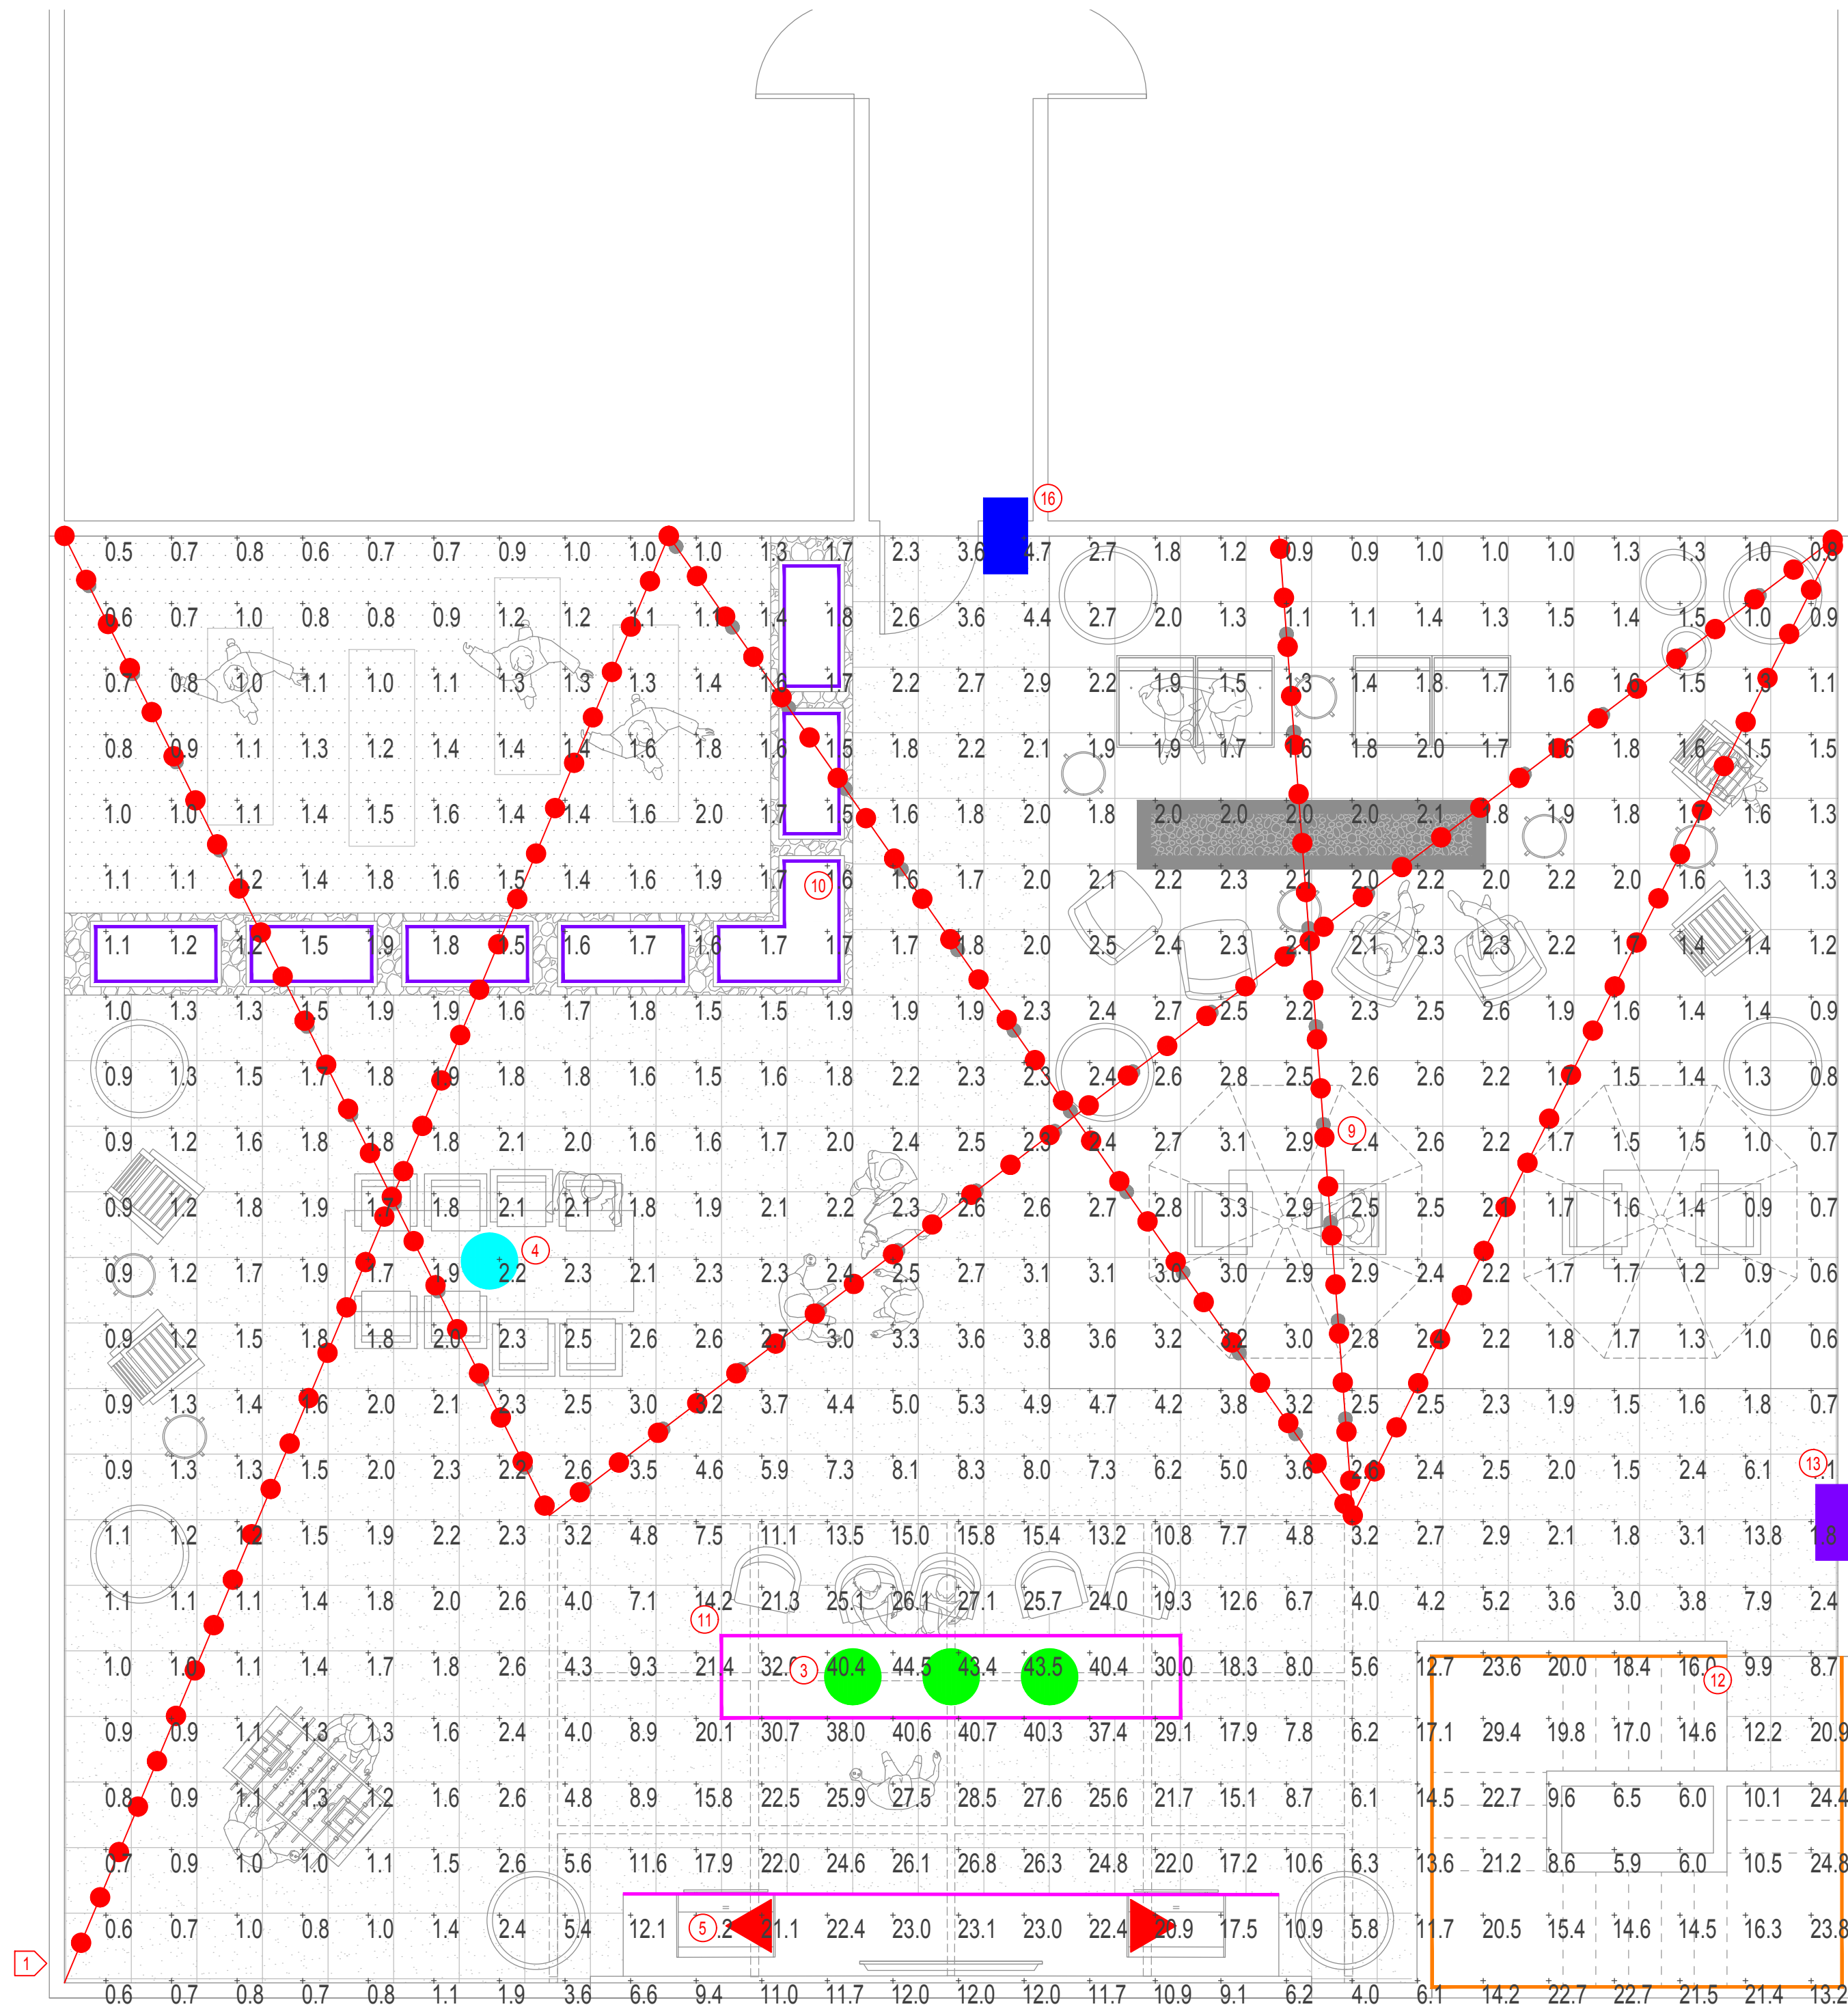

LEVEL 3 AMENITY DECK PHOTOMETRIC
CALCULATION PLAN

LIGHTING LEGEND

- 1 Type AL1 - Stake-mounted Adjustable LED Bullet Accent, 3000K
- 2 Type BH1 - 42" Tall LED Bollard Light, 3000K
- 3 Type DP1 - Decorative Outdoor Pendant, 3000K
- 4 Type DT1 - Decorative Outdoor Table Light, 3000K
- 5 Type FS1 - Surface Mounted LED Bullet Light on Trellis, 3000K
- 6 Type LS1 - Surface Mounted Linear LED Striplight, 3000K
- 7 Type LS2 - Canopy Mounted Linear LED Striplight, 3000K
- 8 Type RD1 - Recessed LED Downlight, 3000K
- 9 Type SC1 - Suspended LED Festoon String, 2500K
- 10 Type SS1 - Surface-mounted Linear LED Tapelight, 3000K
- 11 Type SS2 - Surface-mounted Linear LED Tapelight, 3000K
- 12 Type SZ1 - Handrail integrated LED Lighting, 3000K
- 13 Type WR1 - Wall-recessed LED Step Light, 3000K
- 14 Type WS1 - Surface-mounted LED Wall Sconce, 3000K
- 15 Type WS2 - Surface-mounted LED Wall Pack Light, 3500K
- 16 Type WS3 - Surface-mounted LED Wall Sconce, 3000K
- 17 Type WS4 - Surface-mounted LED Wall Sconce with Uplight and Downlight, 3000K

KEYNOTE


- 1 Add a pole to support the festoon light.

Calculation Summary

Label	CalcType	Units	Avg	Max	Min	Avg/Min	Max/Min	Max/Avg
L3 Amenity Deck	Illuminance	Fc	5.52	44.5	0.5	11.04	89.00	8.06



1/4"=1'-0" 0 2' 4' 8' 12'

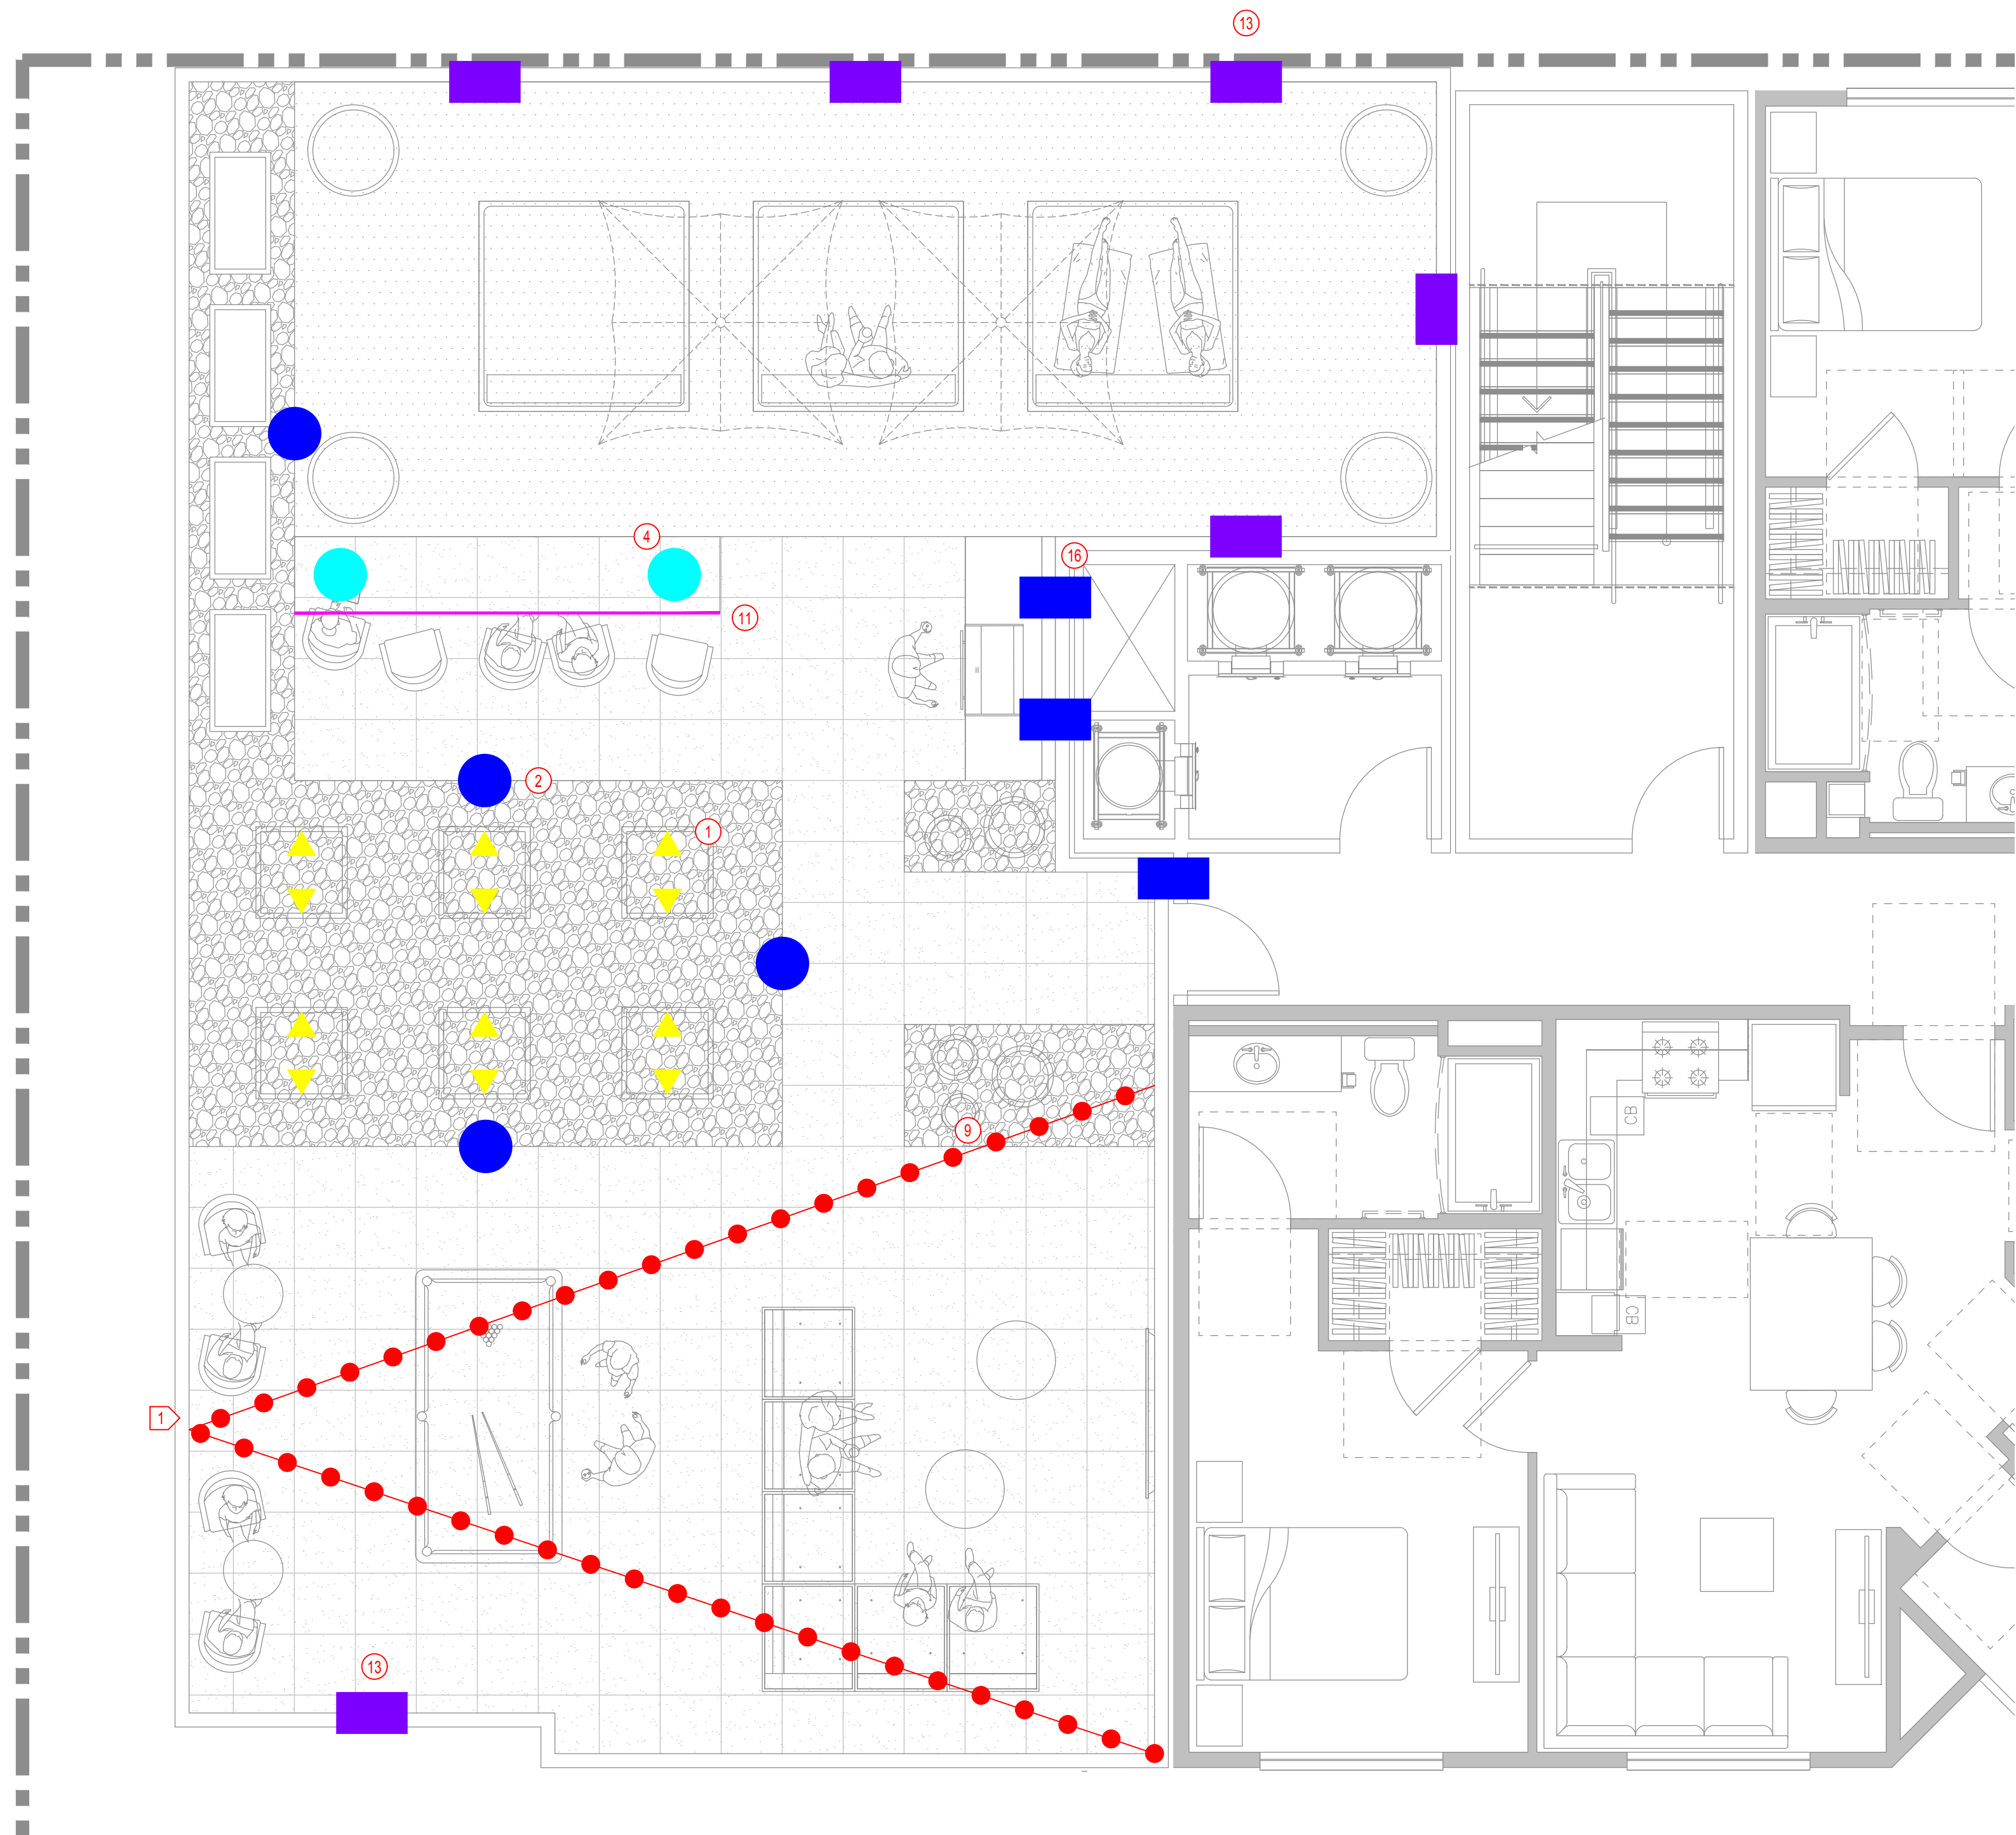


LEVEL 4 AMENITY DECK LIGHTING PLAN

LIGHTING LEGEND

- 1 Type AL1 - Stake-mounted Adjustable LED Bullet Accent, 3000K
- 2 Type BH1 - 42" Tall LED Bollard Light, 3000K
- 3 Type DP1 - Decorative Outdoor Pendant, 3000K
- 4 Type DT1 - Decorative Outdoor Table Light, 3000K
- 5 Type FS1 - Surface Mounted LED Bullet Light on Trellis, 3000K
- 6 Type LS1 - Surface Mounted Linear LED Striplight, 3000K
- 7 Type LS2 - Canopy Mounted Linear LED Striplight, 3000K
- 8 Type RD1 - Recessed LED Downlight, 3000K
- 9 Type SC1 - Suspended LED Festoon String, 2500K
- 10 Type SS1 - Surface-mounted Linear LED Tapelight, 3000K
- 11 Type SS2 - Surface-mounted Linear LED Tapelight, 3000K
- 12 Type SZ1 - Handrail integrated LED Lighting, 3000K
- 13 Type WR1 - Wall-recessed LED Step Light, 3000K
- 14 Type WS1 - Surface-mounted LED Wall Sconce, 3000K
- 15 Type WS2 - Surface-mounted LED Wall Pack Light, 3500K
- 16 Type WS3 - Surface-mounted LED Wall Sconce, 3000K
- 17 Type WS4 - Surface-mounted LED Wall Sconce with Uplight and Downlight, 3000K

KEYNOTE

 - 1 Add a pole to support the festoon light.




LIGHTING LEGEND

- 1 Type AL1 - Stake-mounted Adjustable LED Bullet Accent, 3000K
- 2 Type BH1 - 42" Tall LED Bollard Light, 3000K
- 3 Type DP1 - Decorative Outdoor Pendant, 3000K
- 4 Type DT1 - Decorative Outdoor Table Light, 3000K
- 5 Type FS1 - Surface Mounted LED Bullet Light on Trellis, 3000K
- 6 Type LS1 - Surface Mounted Linear LED Striplight, 3000K
- 7 Type LS2 - Canopy Mounted Linear LED Striplight, 3000K
- 8 Type RD1 - Recessed LED Downlight, 3000K
- 9 Type SC1 - Suspended LED Festoon String, 2500K
- 10 Type SS1 - Surface-mounted Linear LED Tapelight, 3000K
- 11 Type SS2 - Surface-mounted Linear LED Tapelight, 3000K
- 12 Type SZ1 - Handrail integrated LED Lighting, 3000K
- 13 Type WR1 - Wall-recessed LED Step Light, 3000K
- 14 Type WS1 - Surface-mounted LED Wall Sconce, 3000K
- 15 Type WS2 - Surface-mounted LED Wall Pack Light, 3500K
- 16 Type WS3 - Surface-mounted LED Wall Sconce, 3000K
- 17 Type WS4 - Surface-mounted LED Wall Sconce with Uplight and Downlight, 3000K

KEYNOTE

- 1 Add a pole to support the festoon light.

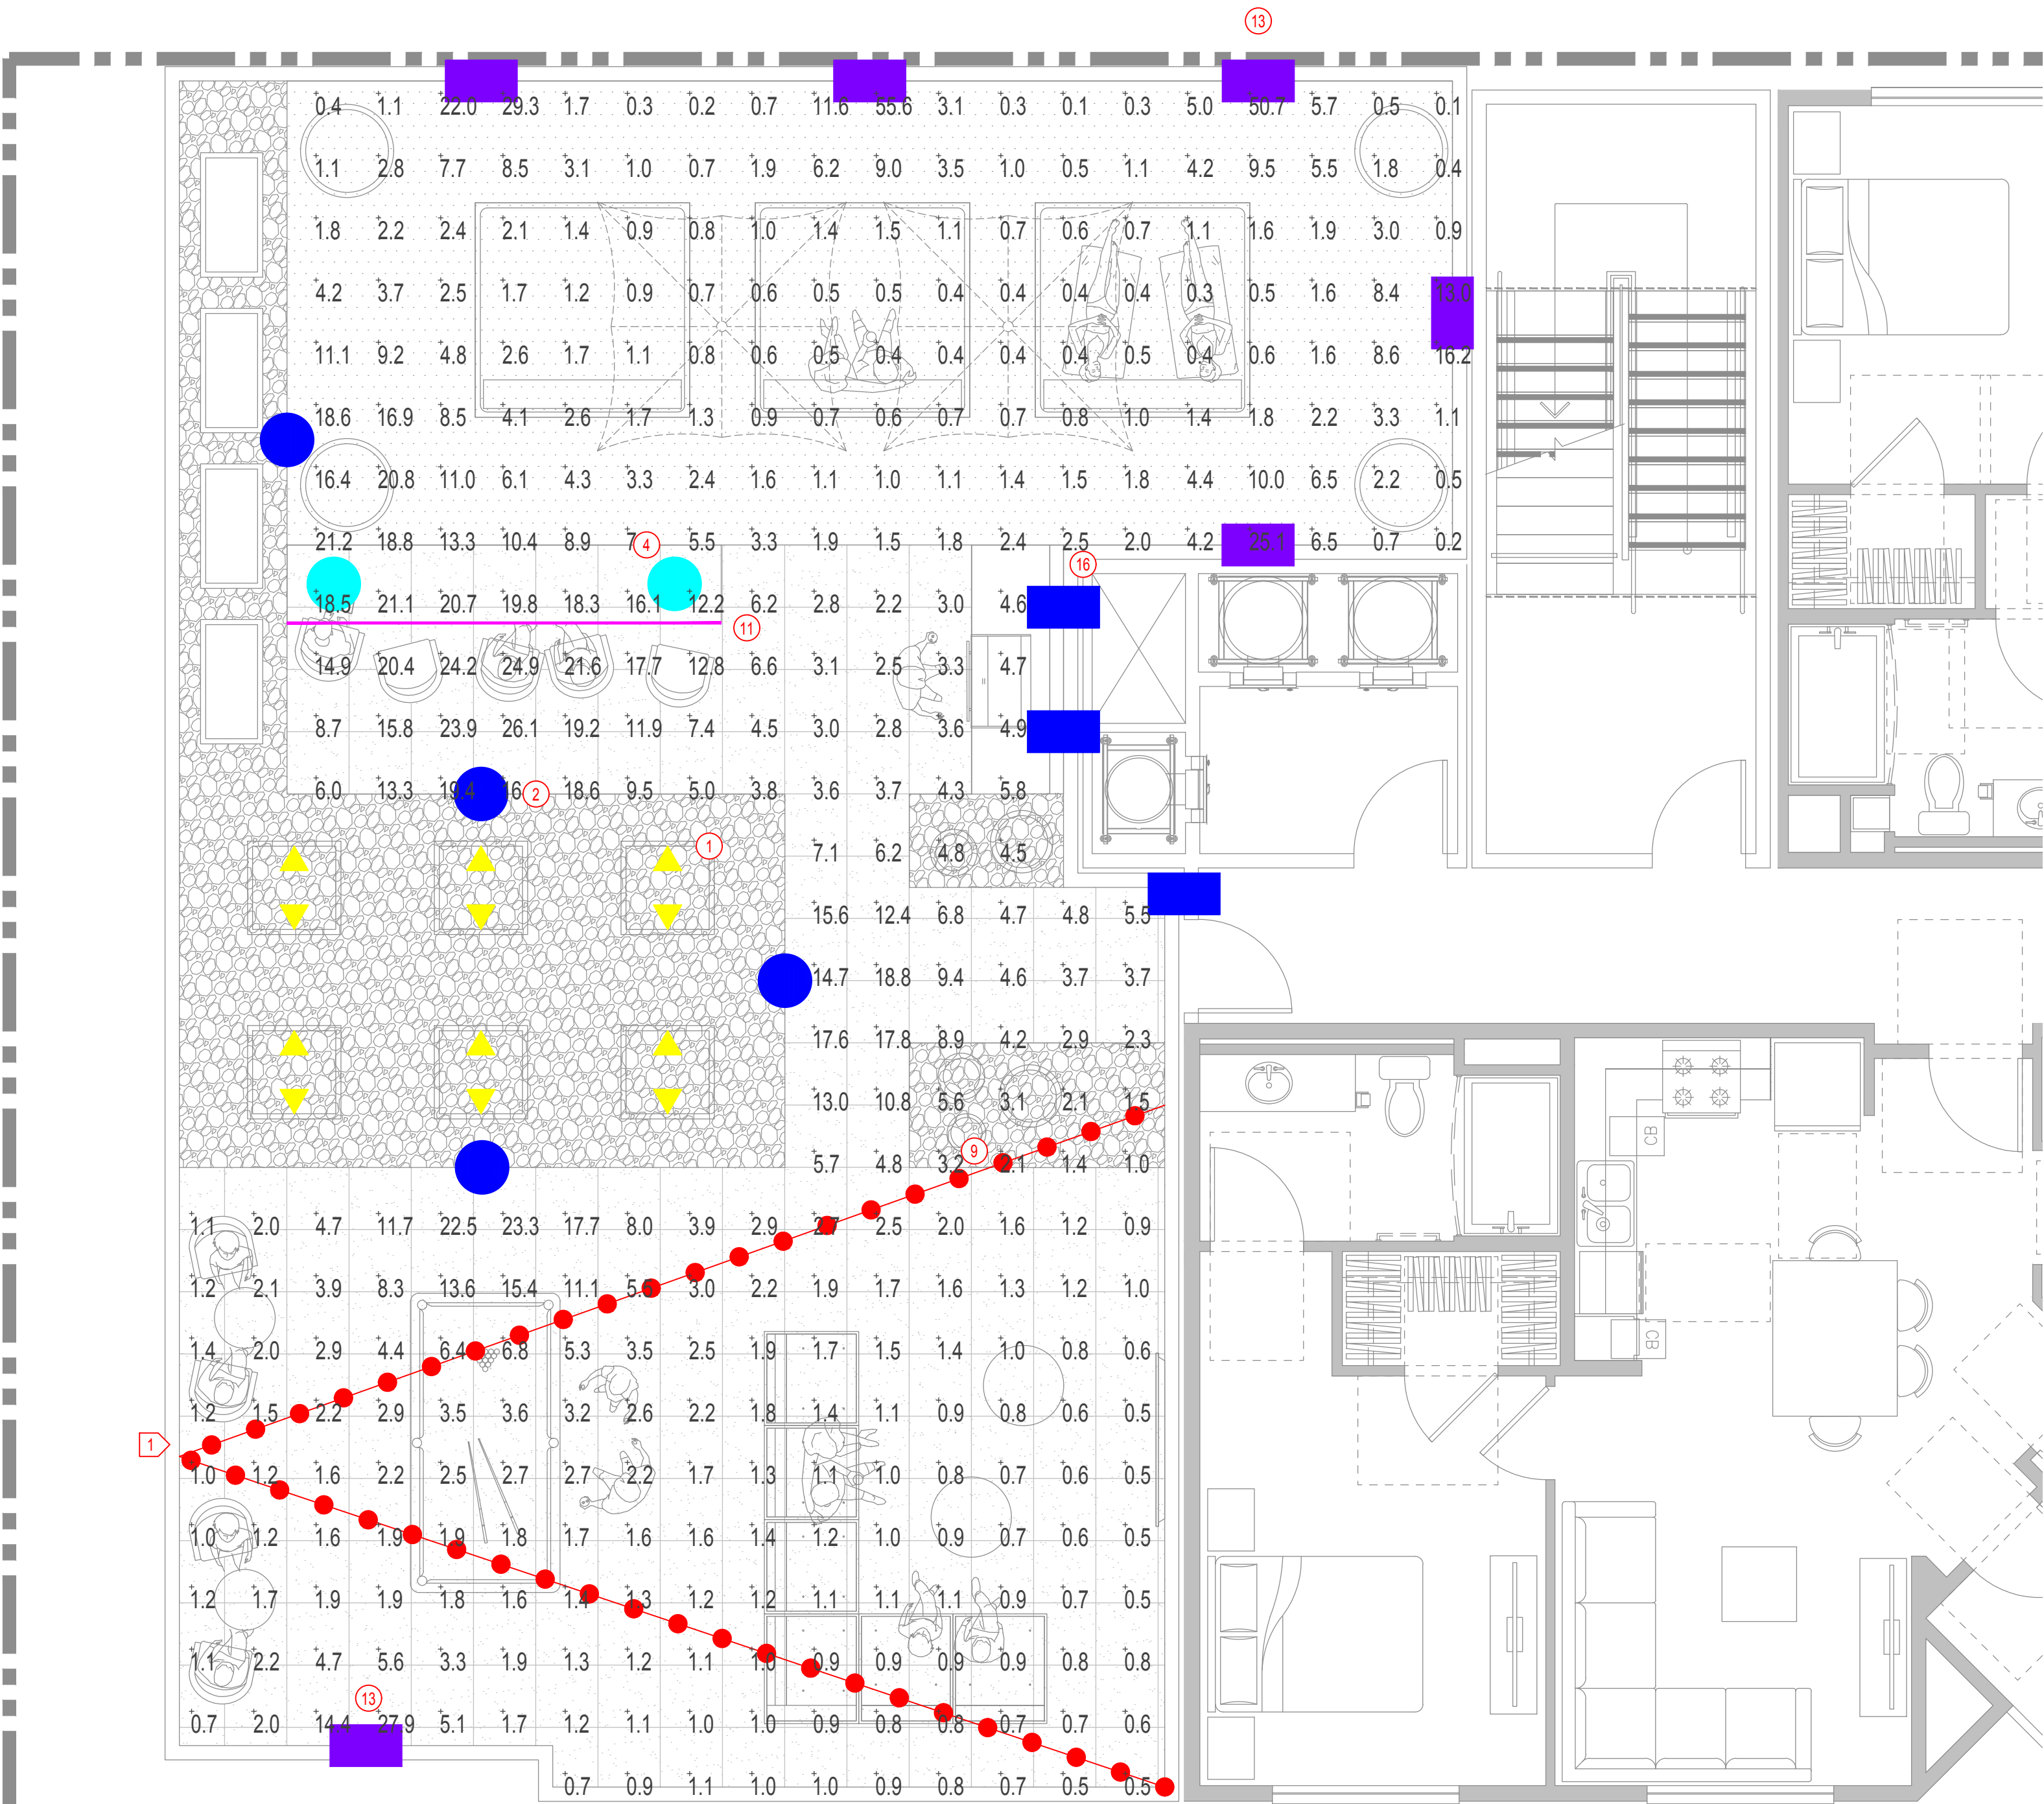

Calculation Summary									
Label	CalcType	Units	Avg	Max	Min	Avg/Min	Max/Min	Max/Avg	
L4 Amenity Deck	Illuminance	Fc	4.87	55.6	0.1	48.70	556.00	11.42	

LEVEL 4 AMENITY DECK PHOTOMETRIC
CALCULATION PLAN



1/4"=1'-0"
0 2' 4' 8' 12'



FRONT ELEVATION 1



RIGHT ELEVATION 2


LIGHTING LEGEND

- ① ▲ Type AL1 - Stake-mounted Adjustable LED Bullet Accent, 3000K
- ② ● Type BH1 - 42" Tall LED Bollard Light, 3000K
- ③ ● Type DP1 - Decorative Outdoor Pendant, 3000K
- ④ ● Type DT1 - Decorative Outdoor Table Light, 3000K
- ⑤ ▲ Type FS1 - Surface Mounted LED Bullet Light on Trellis, 3000K
- ⑥ — Type LS1 - Surface Mounted Linear LED Striplight, 3000K
- ⑦ — Type LS2 - Canopy Mounted Linear LED Striplight, 3000K
- ⑧ ■ Type RD1 - Recessed LED Downlight, 3000K
- ⑨ --- Type SC1 - Suspended LED Festoon String, 2500K
- ⑩ — Type SS1 - Surface-mounted Linear LED Tapelight, 3000K
- ⑪ — Type SS2 - Surface-mounted Linear LED Tapelight, 3000K
- ⑫ — Type SZ1 - Handrail integrated LED Lighting, 3000K
- ⑬ ■ Type WR1 - Wall-recessed LED Step Light, 3000K
- ⑭ ■ Type WS1 - Surface-mounted LED Wall Sconce, 3000K
- ⑮ ■ Type WS2 - Surface-mounted LED Wall Pack Light, 3500K
- ⑯ ■ Type WS3 - Surface-mounted LED Wall Sconce, 3000K
- ⑰ ■ Type WS4 - Surface-mounted LED Wall Sconce with Uplight and Downlight, 3000K

KEYNOTE

- ① Add a pole to support the festoon light.

KEY MAP

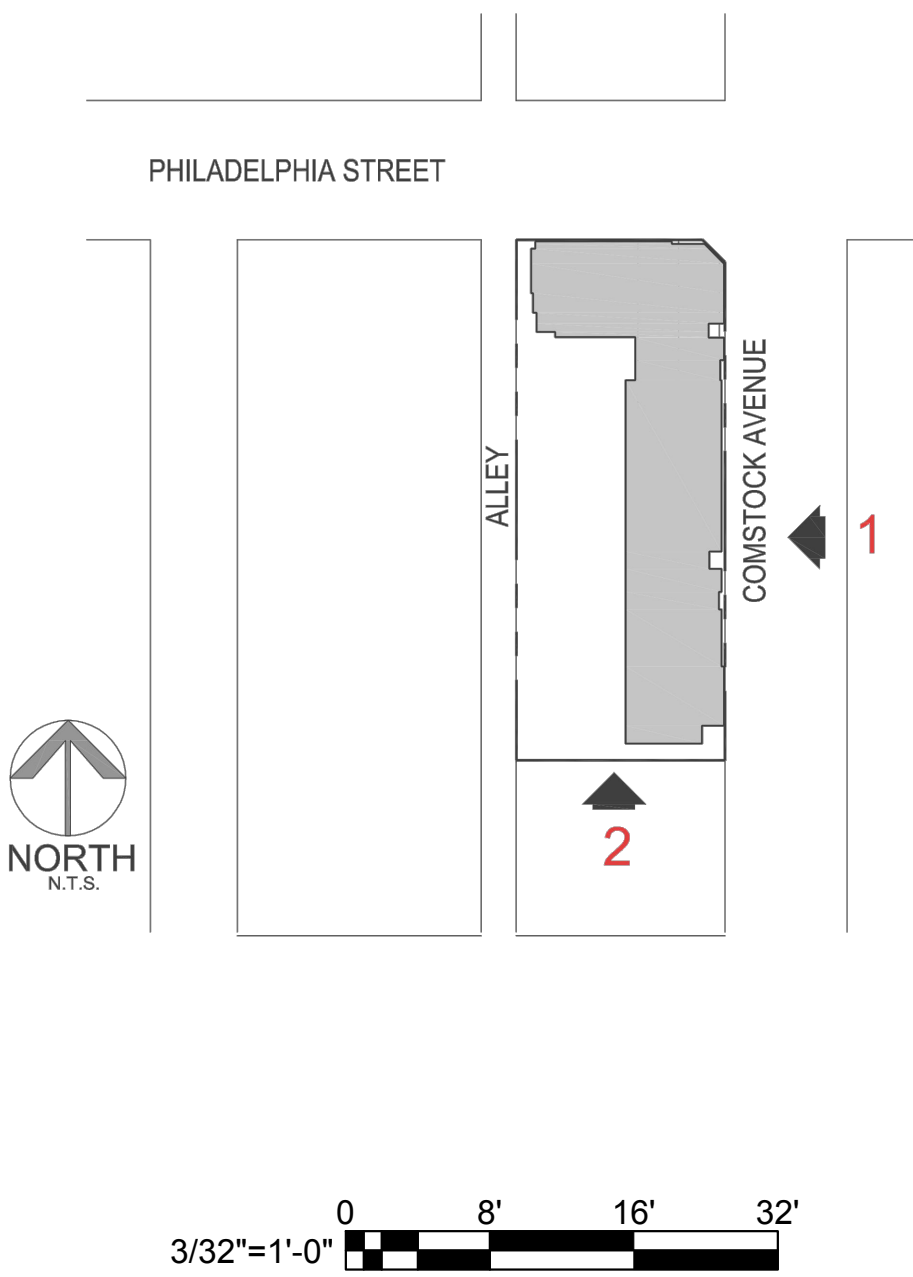

THE COMSTOCK
WHITTIER, CA

**EXTERIOR
LIGHTING
ELEVATIONS**

LD5.0



REAR ELEVATION 3



LEFT ELEVATION 4


LIGHTING LEGEND

- 1 ▲ Type AL1 - Stake-mounted Adjustable LED Bullet Accent, 3000K
- 2 ● Type BH1 - 42" Tall LED Bollard Light, 3000K
- 3 ● Type DP1 - Decorative Outdoor Pendant, 3000K
- 4 ● Type DT1 - Decorative Outdoor Table Light, 3000K
- 5 ▲ Type FS1 - Surface Mounted LED Bullet Light on Trellis, 3000K
- 6 ■ Type LS1 - Surface Mounted Linear LED Striplight, 3000K
- 7 ■ Type LS2 - Canopy Mounted Linear LED Striplight, 3000K
- 8 ■ Type RD1 - Recessed LED Downlight, 3000K
- 9 --- Type SC1 - Suspended LED Festoon String, 2500K
- 10 ■ Type SS1 - Surface-mounted Linear LED Tapelight, 3000K
- 11 ■ Type SS2 - Surface-mounted Linear LED Tapelight, 3000K
- 12 ■ Type SZ1 - Handrail integrated LED Lighting, 3000K
- 13 ■ Type WR1 - Wall-recessed LED Step Light, 3000K
- 14 ■ Type WS1 - Surface-mounted LED Wall Sconce, 3000K
- 15 ■ Type WS2 - Surface-mounted LED Wall Pack Light, 3500K
- 16 ■ Type WS3 - Surface-mounted LED Wall Sconce, 3000K
- 17 ■ Type WS4 - Surface-mounted LED Wall Sconce with Uplight and Downlight, 3000K

KEYNOTE

- 1 Add a pole to support the festoon light.

KEY MAP

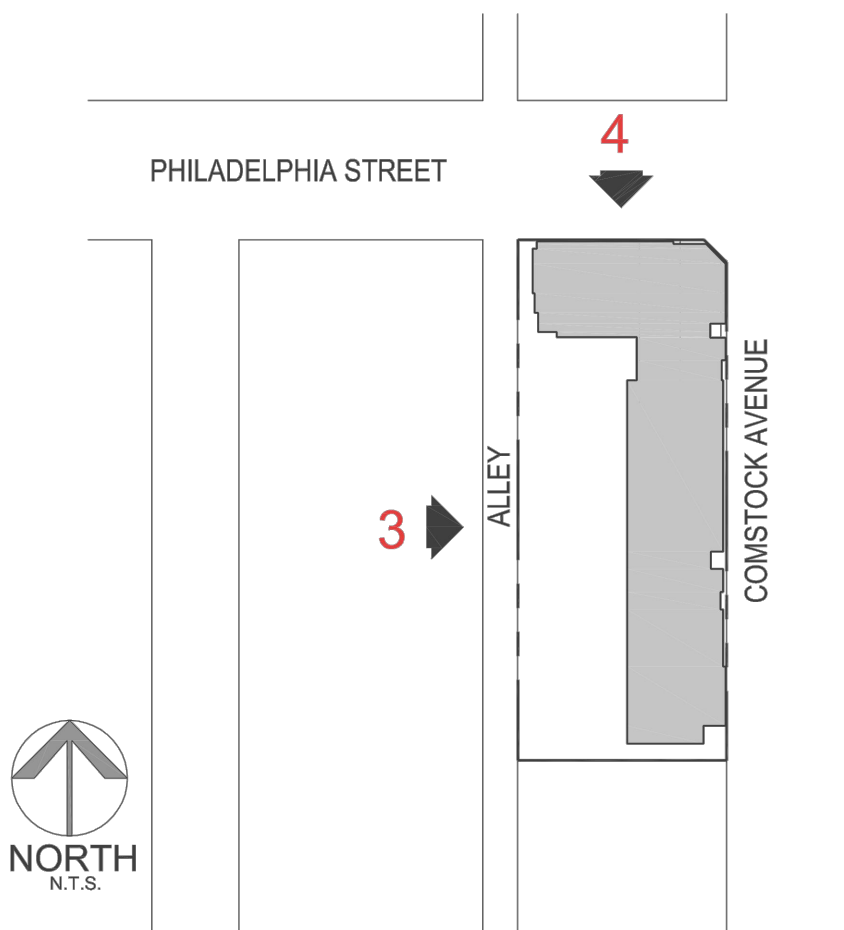


LIGHT FIXTURE - TYPE WS4

Rev: 2021/04/01


OW2213 – Pig
3 Round Accents




Photometrics (per direction - up/down)

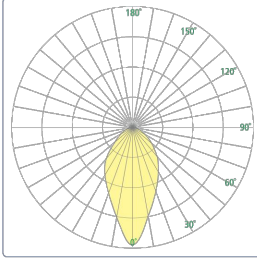

MED 50° Beam

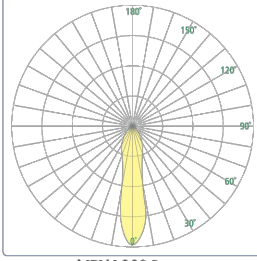

NRW 23° Beam

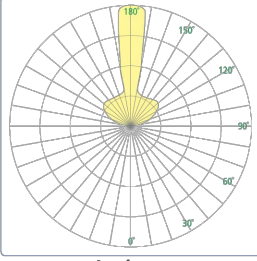


Luminous

Technical Information


- Integral high power factor electronic power supply with MVOLT operation in wall bracket canopy
- Modular design for replacement of LED source and power supply
- IP65 rated
- Bracket mounting system simplifies installation and maintenance
- Mounts over 4" junction box
- Tamper resistant fasteners
- Meets seismic guidelines for weight
- Cast and fabricated aluminum
- Luminous housing is clear high impact grade acrylic, inner cylinder is frosted acrylic
- No VOC powder coat paint finish

Relative Scale Drawing

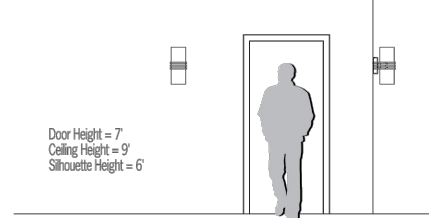

Path of Egress

133K, 50 degree beam spread, downlight only,
mounted 16" above grade, 70' light loss factor used

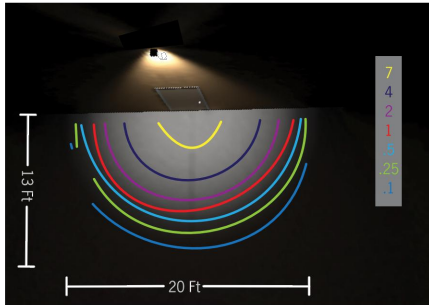

Luminous Uplight
50° Downlight



Pencil Beam Uplight
Luminous Downlight



Pencil Beam Uplight
50° Downlight



800-788-VISA

VisaLighting.com

Page 2



Lighting Consultant

LIGHTING DESIGN ALLIANCE

2830 TEMPLE AVE. LONG BEACH, CA 90804-2215, USA
T: 562.989.3843 F: 562.989.3847
www.LightingDesignAlliance.com

Landscape Architect

Client

MW INVESTMENT
GROUP, LLC

27702 CROWN VALLEY
PARKWAY, SUITE D-3-197
LADERA RANCH, CA 92694

THE COMSTOCK
WHITTIER, CA

LIGHTING
SPECIFICATIONS

LD6.3

Project Number: 2021-121
Plan Check Number:

LIGHTING SPECIFICATIONS